


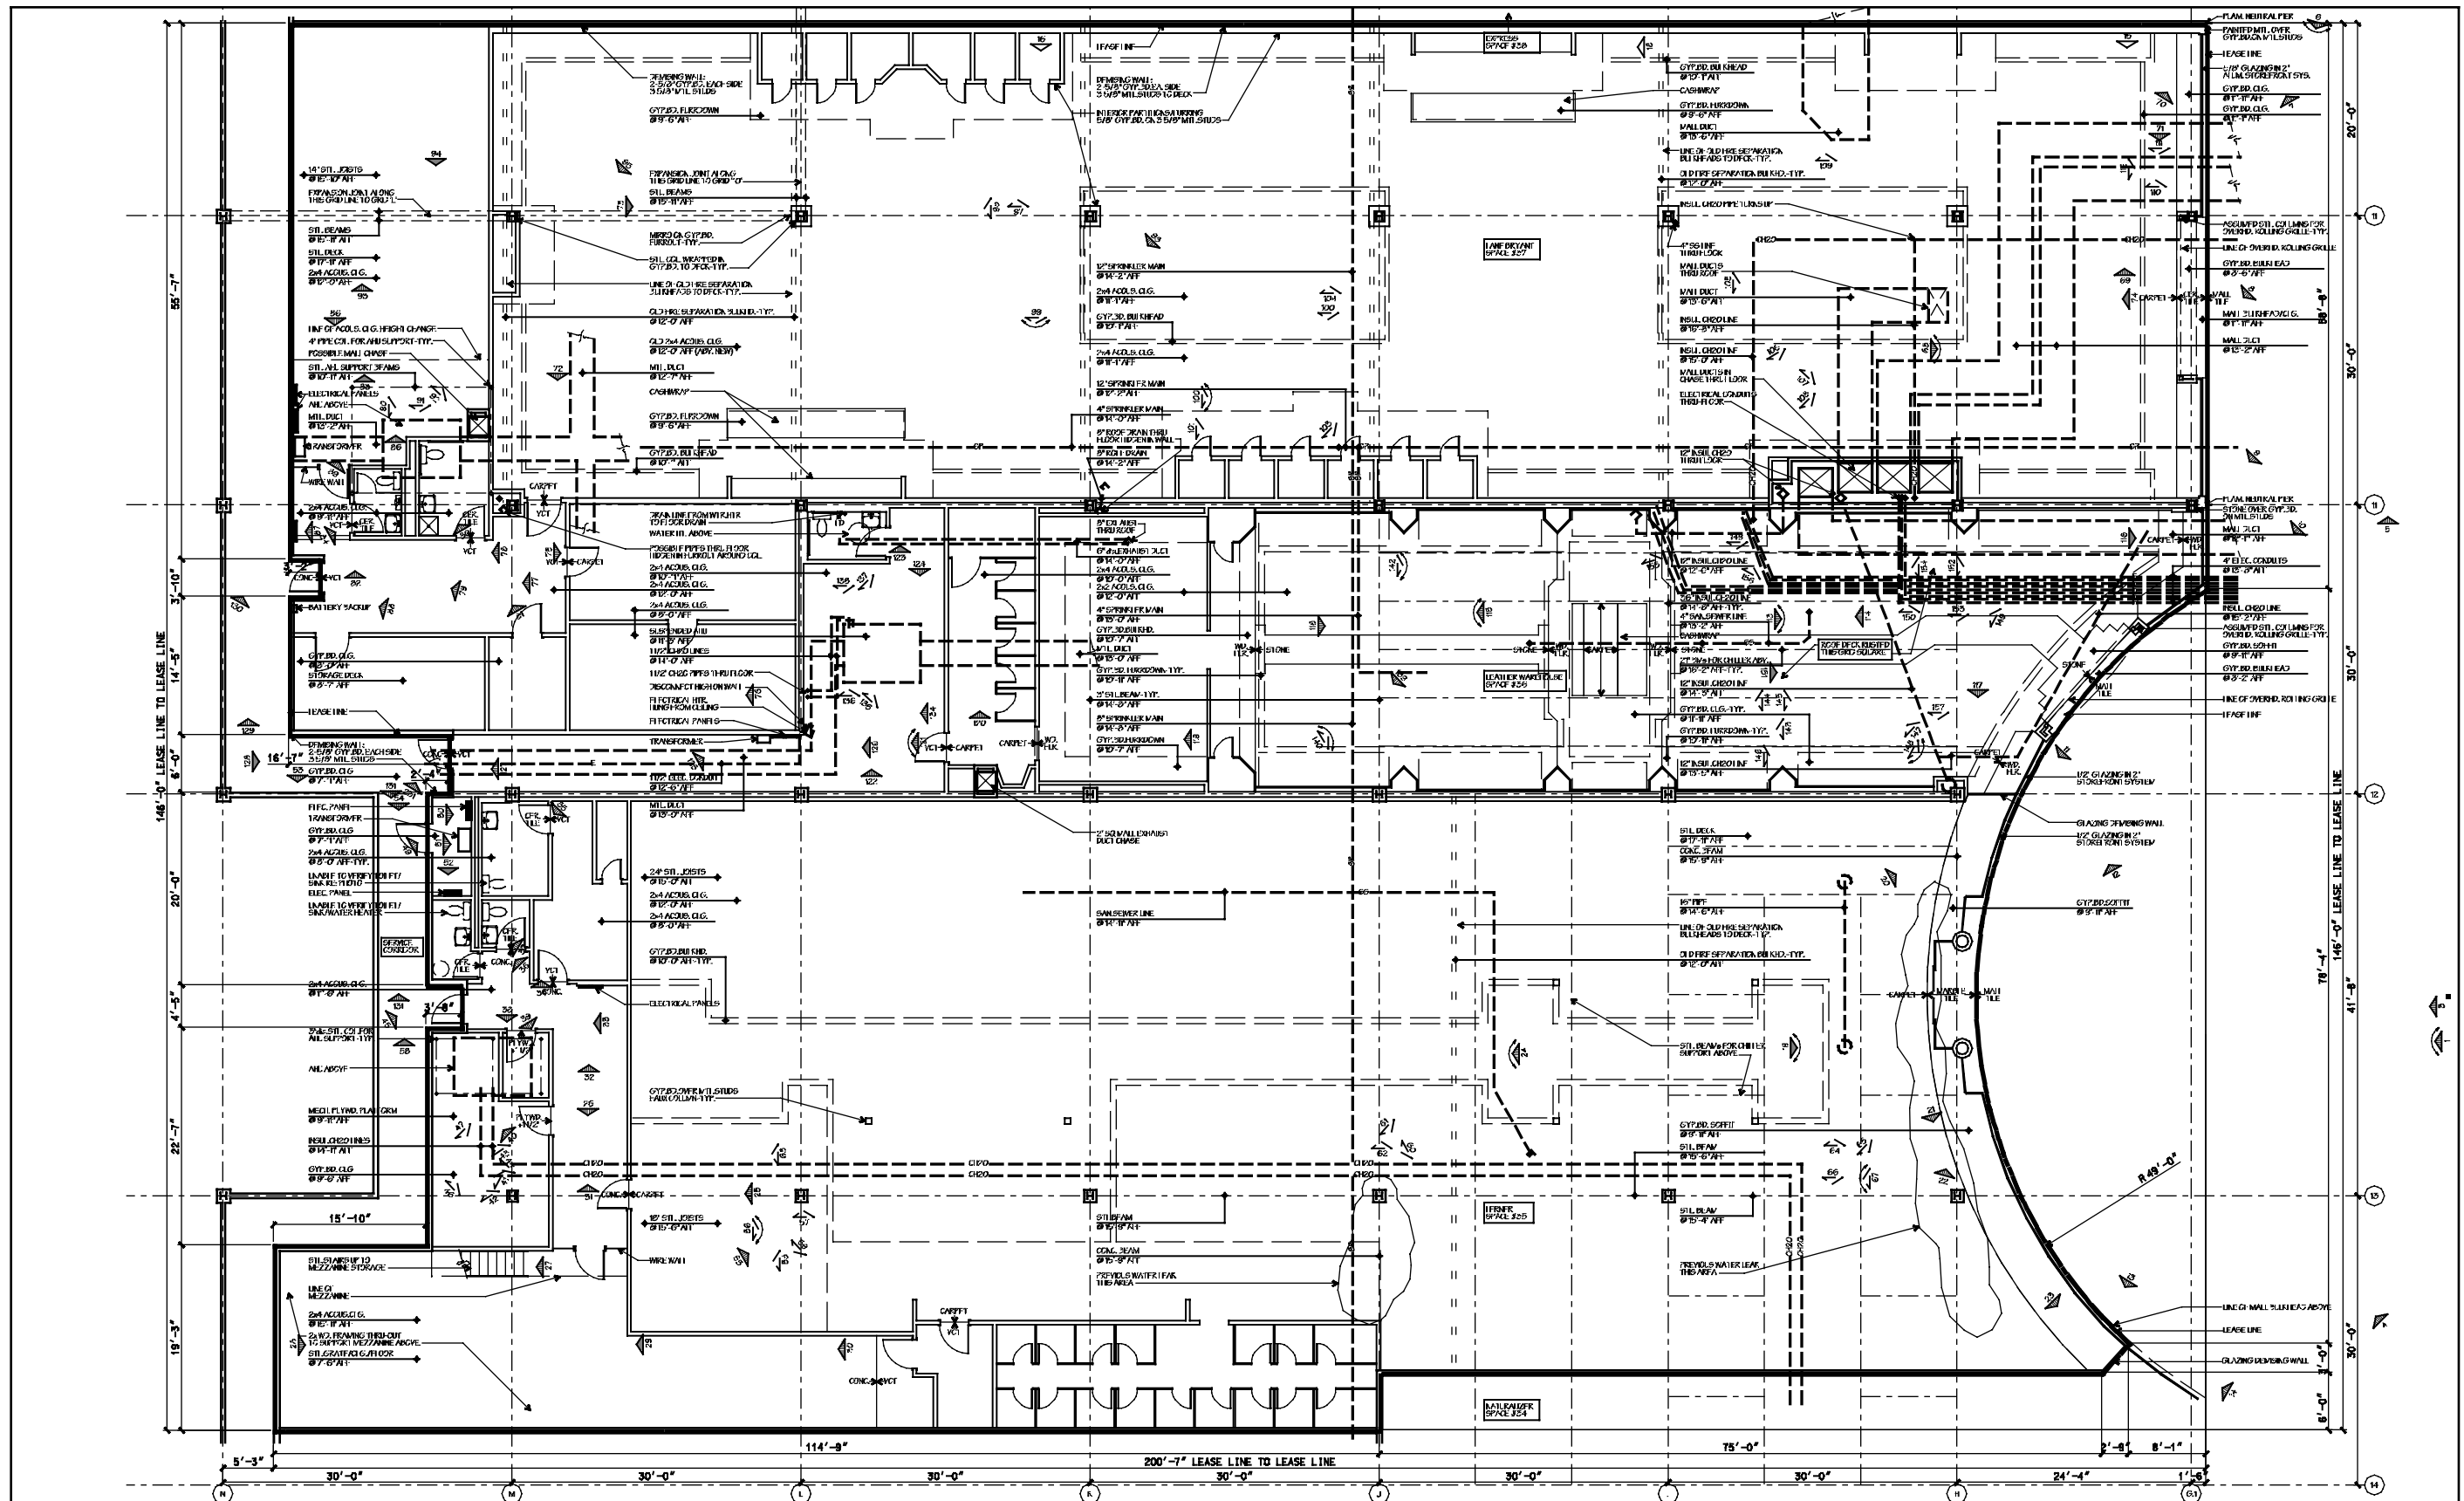

FLOOR PLAN 1/8" = 1'-0" 1

LEGEND: DEMISING WALL INTERIOR WALL CMU WALL LEASE LINE COL. GRID ELEVATION SYM.	MISC. PIPE SPRINKLER CHILLED WATER GAS ELECTRICAL SEWER PLUMBING VENT FLOOR DRAIN ROOF DRAIN	PHOTO LOCATION BELOW CLG. PHOTO LOCATION PANORAMIC PHOTO LOCATION 360° PANORAMIC PHOTO LOCATION ABOVE CLG. PHOTO LOCATION ABOVE CLG. PAN	PHOTO LOCATION ABOVE CLG. PHOTO LOCATION 360° PANORAMIC PHOTO LOCATION AT ROOF PHOTO LOCATION AT ROOF PANORAMIC PHOTO LOCATION AT ROOF 360° PANORAMIC	PREPARED FOR:	Morrison & Associates Environmental Design and Management, Inc. 501 Alpine Circle 405/360-5625 Norman, OK 73069 FAX 405/321-0517	Survey at: Livingston Mall 112 Eisenhower Parkway Livingston, New Jersey 07039 Client Store No: TBA Map Project No: 35,36,37 Space Number: 27,160 SF Lease Area (LDCS/LOD): 26,340 SF Lease Area (Verified):	Drawn By: JH Checked By: JH Issue Date: 3.10.00 Sheet: 2 of 2
--	---	---	--	----------------------	--	---	--